 



FOR ELECTRICAL LEGEND PLEASE REFER TO GUARDHOUSE DRAWING PG. 03

**NOTES:**

1. All electrical appliances to be according to the manufacturers design.
2. Loose Furniture and Electrical appliances shown for illustration purposes only.

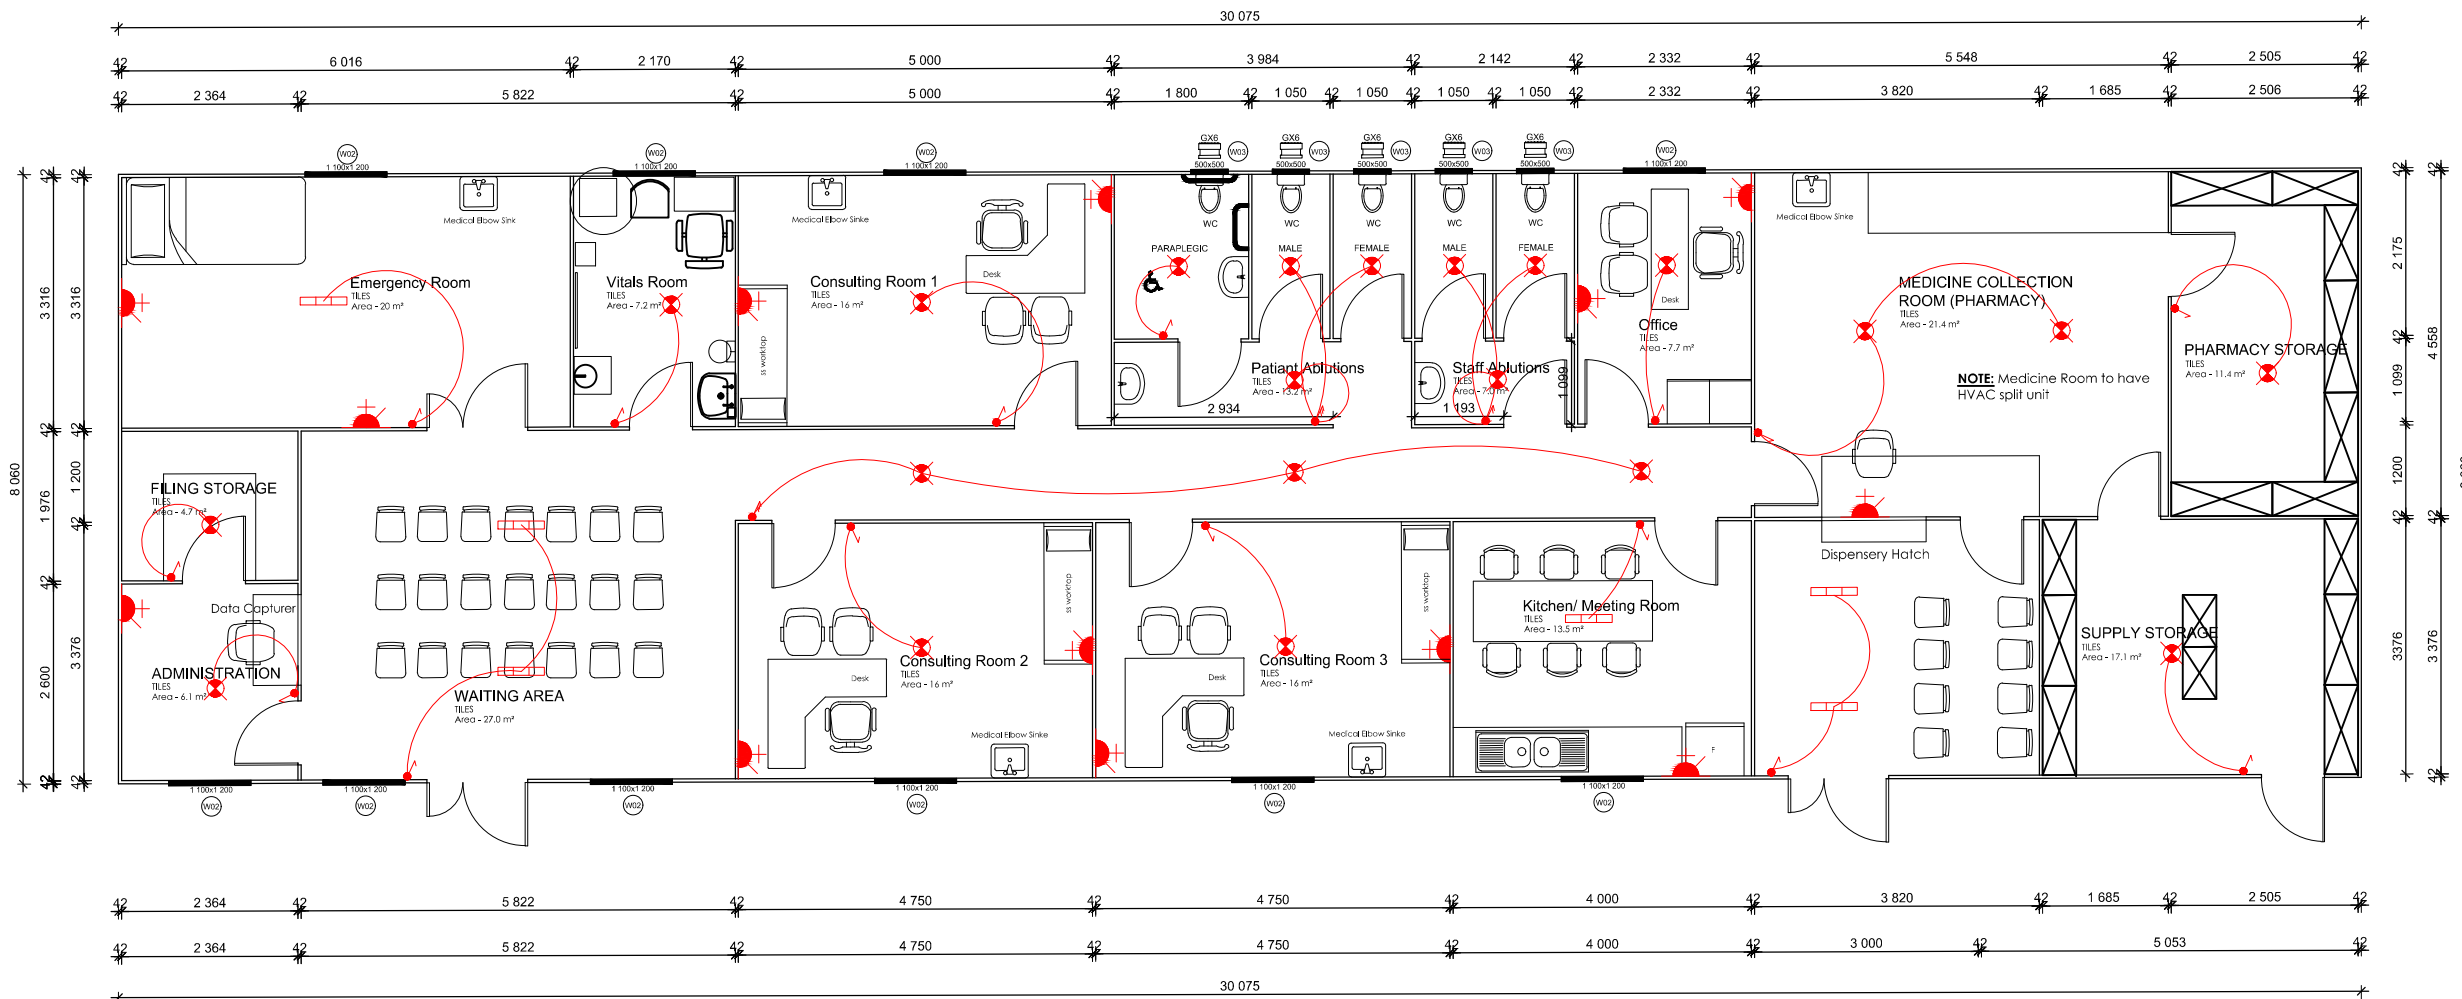

**Clinic Floor Plan**  
**SCALE 1:100**  
 AREA 243.0 m<sup>2</sup>

STAMP

COPY RIGHTS RESERVED

**NOTE:**

1. This drawing may not be scaled. Only figured dimensions and levels may be used.
2. All Dimensions and levels to be checked on site before commencement of work.
3. Refer any discrepancies to the Architect immediately.
4. All work to be carried out in accordance with local authority requirements, National Building Regulations, and relevant S.A.B.S. standards.

**Revisions:**

Revision no.:	Date:	Description:	Checked By:

Project Leader: Khaya Buthelezi

Drawn By: Sihle Ntsele

District: Zululand

Project Title:  
**PROPOSED NEW PARKHOME FOR KWAGWEBU CLINIC, VRYHEID**

Drawing Description: Floor Plans



PROJ. No.:

Scale: As Shown Page Size: A3

Drawing Number: VRY-KGC-17/03

Date: MARCH 2023 Page no.: 01

35 HYSLOP ROAD TOWNHILL  
 OFFICE PARK, BLOCK 1  
 PIETERMARITZBURG  
 3201